


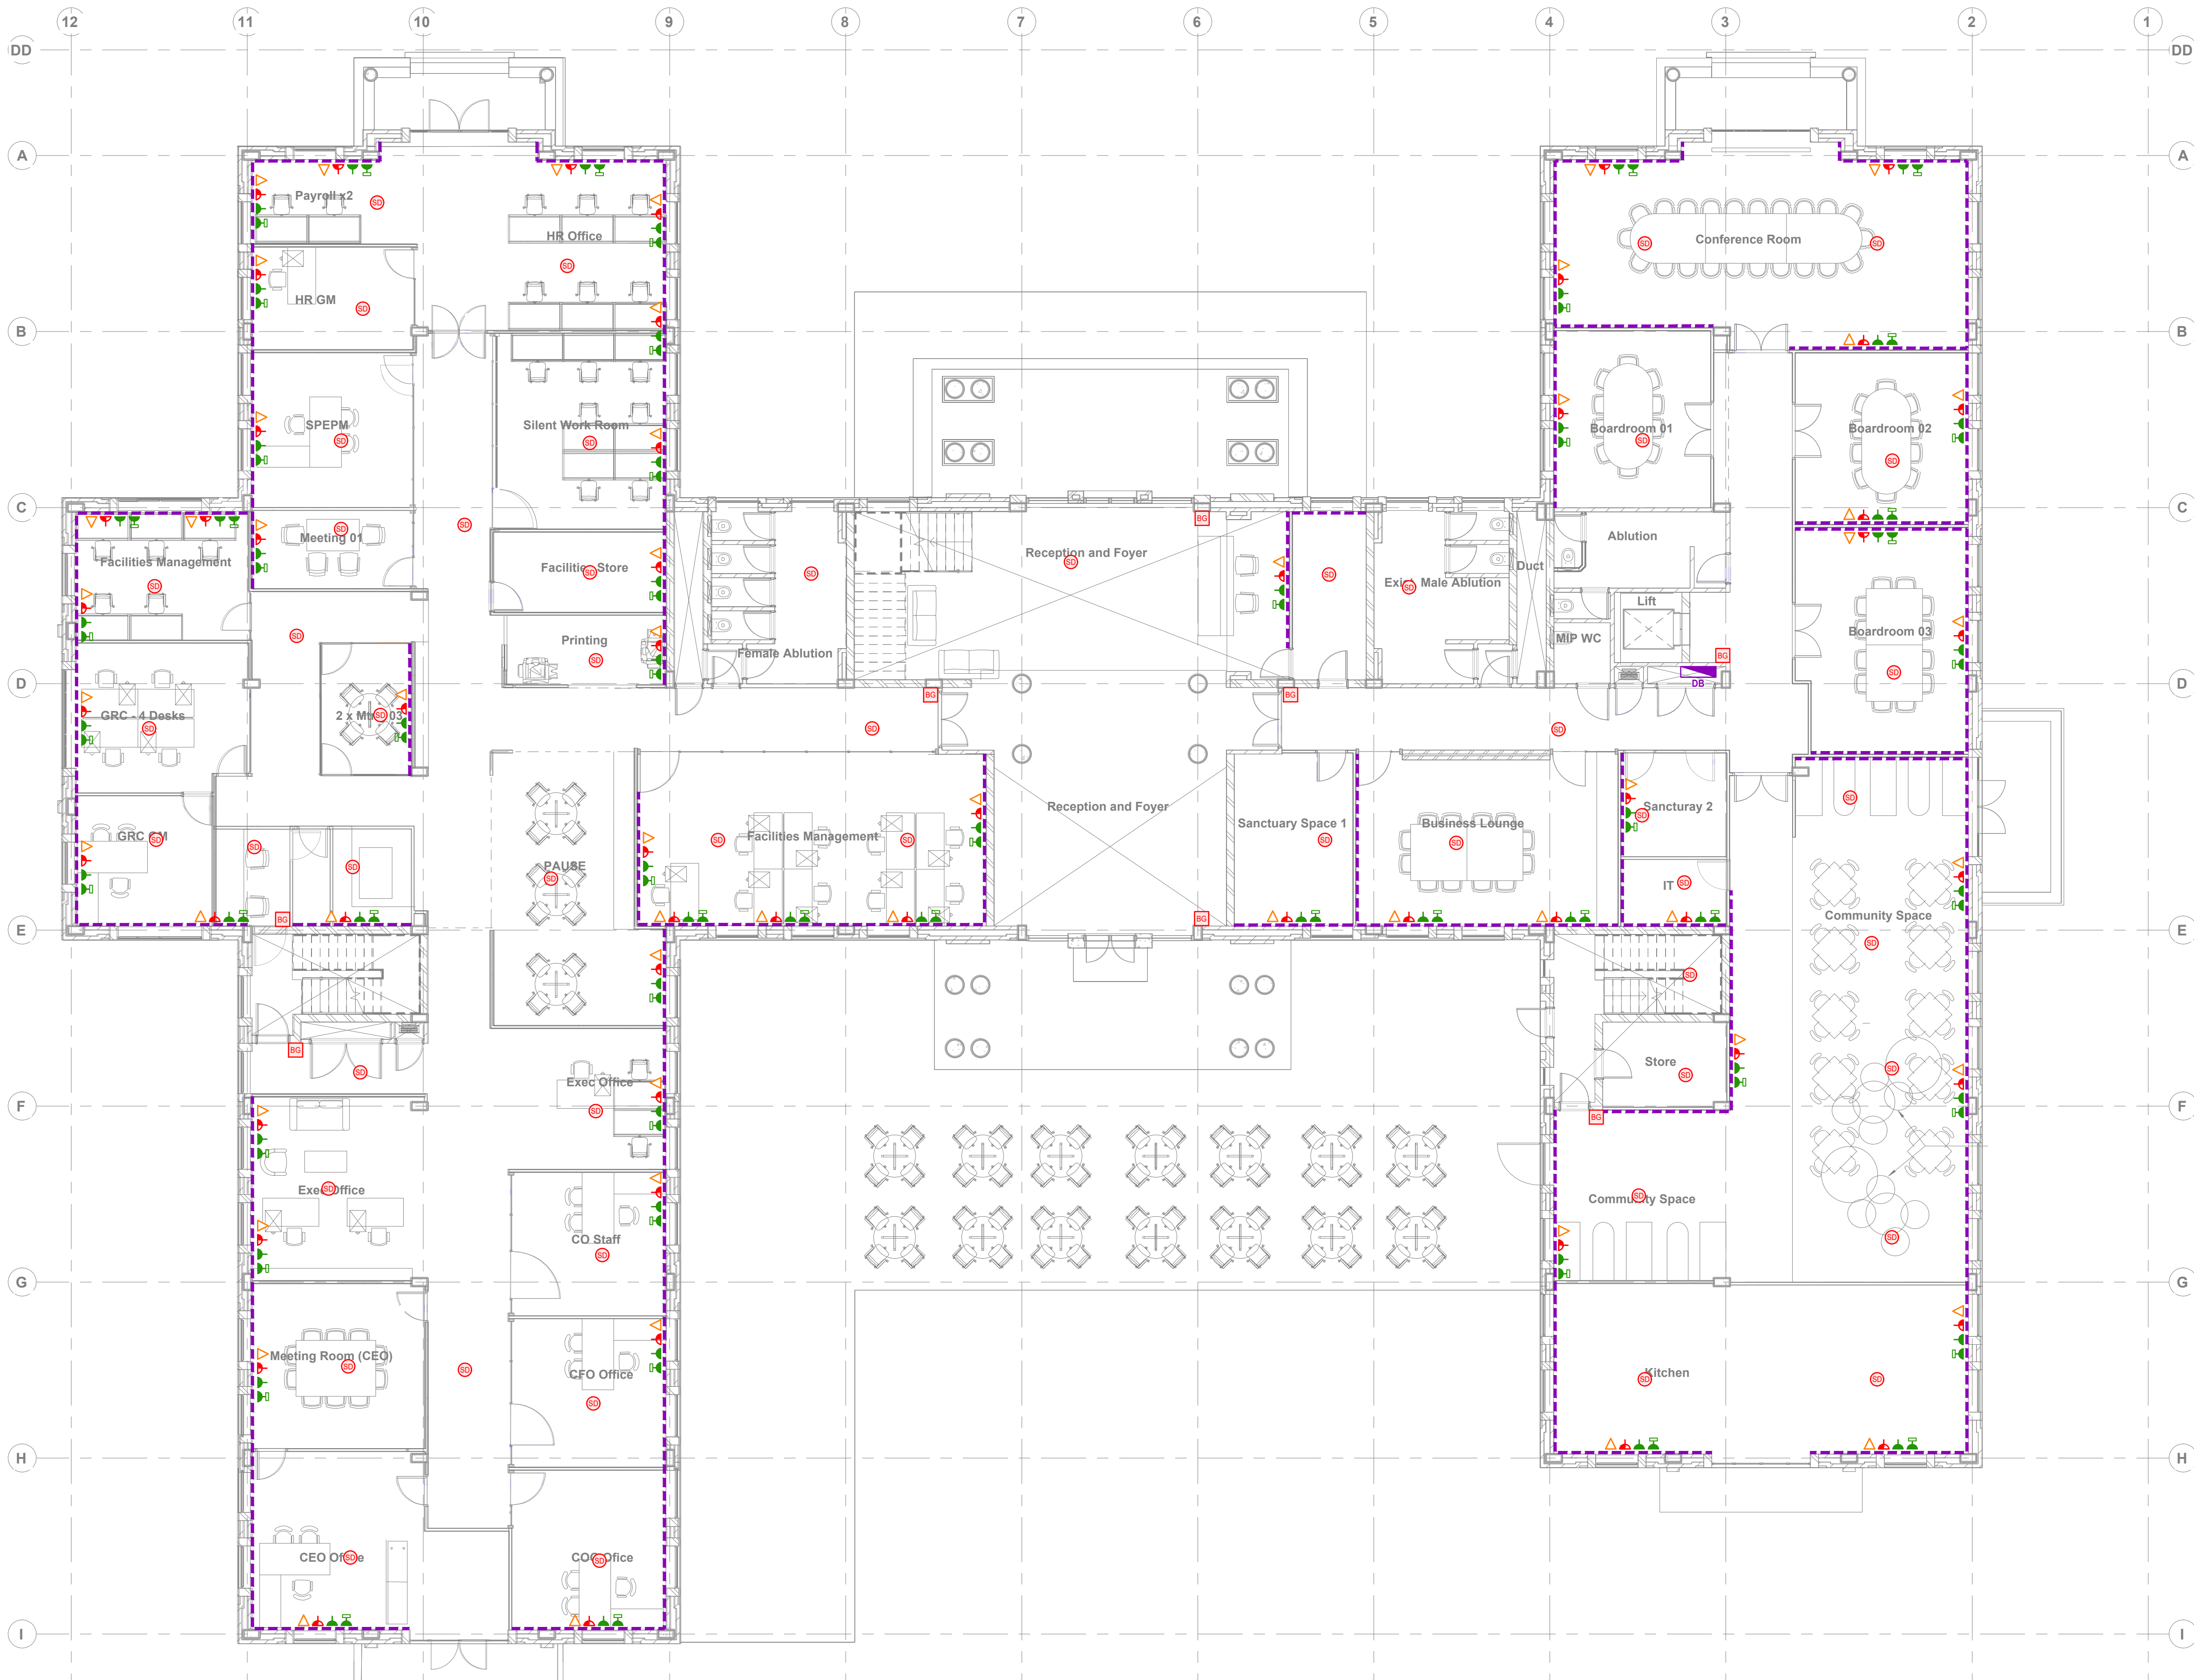

GENERAL NOTES

- A) THE ELECTRICAL INSTALLATION AND COMPONENTS SHALL BE SELECTED, PROCURED AND INSTALLED STRICTLY IN ACCORDANCE WITH THE OCCUPATIONAL HEALTH AND SAFETY ACT (ACT 85 OF 1993), SANS10142 PART 1 & 2 (THE WIRING OF PREMISES) AND SANS10400 (BUILDING REGULATIONS).
- B) THIS DRAWING IS TO BE READ IN CONJUNCTION WITH ALL RELEVANT DRAWINGS AND CONTRACT SPECIFICATIONS, WHICH CAN BE MADE AVAILABLE ON REQUEST.
- C) ANY DISCREPANCIES SHOULD BE BROUGHT TO CONSULTANTS ATTENTION PRIOR TO IMPLEMENTATION OF ANY WORK.
- D) ANY DRAWING IS ONLY CONTRACTUALLY VALID IF:
- STAMPED FOR CONSTRUCTION/PRELIMINARY INFORMATION.
- SIGNED IN BOTH THE CHECKED AND APPROVED BOXES.
- E) LOW VOLTAGE & MEDIUM VOLTAGE SWITCHGEAR, CABLES, ACCESSORIES, ASSEMBLIES, INSTALLATION METHODS AND MATERIALS ARE TO BE FULLY SANS COMPLIANT AND ARE TO BARE THE SABS STAMP OF APPROVAL WHERE REQUIRED.
- F) ALL ELECTRICAL WALL OUTLETS ARE MEASURED FROM THE TOP OF THE FINISHED FLOOR LEVEL TO THE BOTTOM EDGE OF THE WALL BOX.

ELECTRICAL LEGEND

	DISTRIBUTION BOARD
	NORMAL SINGLE SOCKET OUTLET FOR POWER
	NORMAL EURO 2PIN SOCKET OUTLET FOR POWER
	DEDICATED SINGLE SOCKET OUTLET FOR POWER
	DATA BLANK
	SOCKET OUTLET FOR POWER
	3 COMPARTMENT, 2 COVER POWER SKIRTING - BLACK
	SMOKE DETECTION
	RED BREAKGLASS UNIT

GROUND FLOOR
SMALL POWER LAYOUT
SCALE 1:100

REV	DATE	BY	DESCRIPTION	CHK	APP
B	12-09-2025	D.A.	ISSUED FOR INFORMATION	S.R.	S.R.
A	10-09-2025	D.A.	ISSUED FOR INFORMATION	S.R.	S.R.
DRAWING STATUS: FOR INFORMATION					

ANDERSON CONSULTING ENGINEERS (PTY) LTD
www.aceng.co.za

CLIENT: SA TOURISM

ARCHITECT: **THE GREY & WHIPPET**
ARCHITECTURE

PROJECT: SA TOURISM BUILDING
OFFICE REVAMP

TITLE: ELECTRICAL SERVICES
GROUND FLOOR
SMALL POWER LAYOUT

SCALE @ A1: 1:100	CHECKED: SR	APPROVED: SR
CAD FILE: 24076-E101	DESIGN/DRAWN: SR / DA	DATE: 19-08-2025
PROJECT No: 24076	DRAWING No: E101	REV: B
© Anderson Consulting Engineers (Pty) Ltd		