


P:\ACE Drawings\24076-SA Tourism Building\Drawings\Electrical\24076-E100 - Rev.B - SA Tourism Building - Ground Floor - Lighting Layout - A1.dwg 12 Sep. 2025 - 9:15am

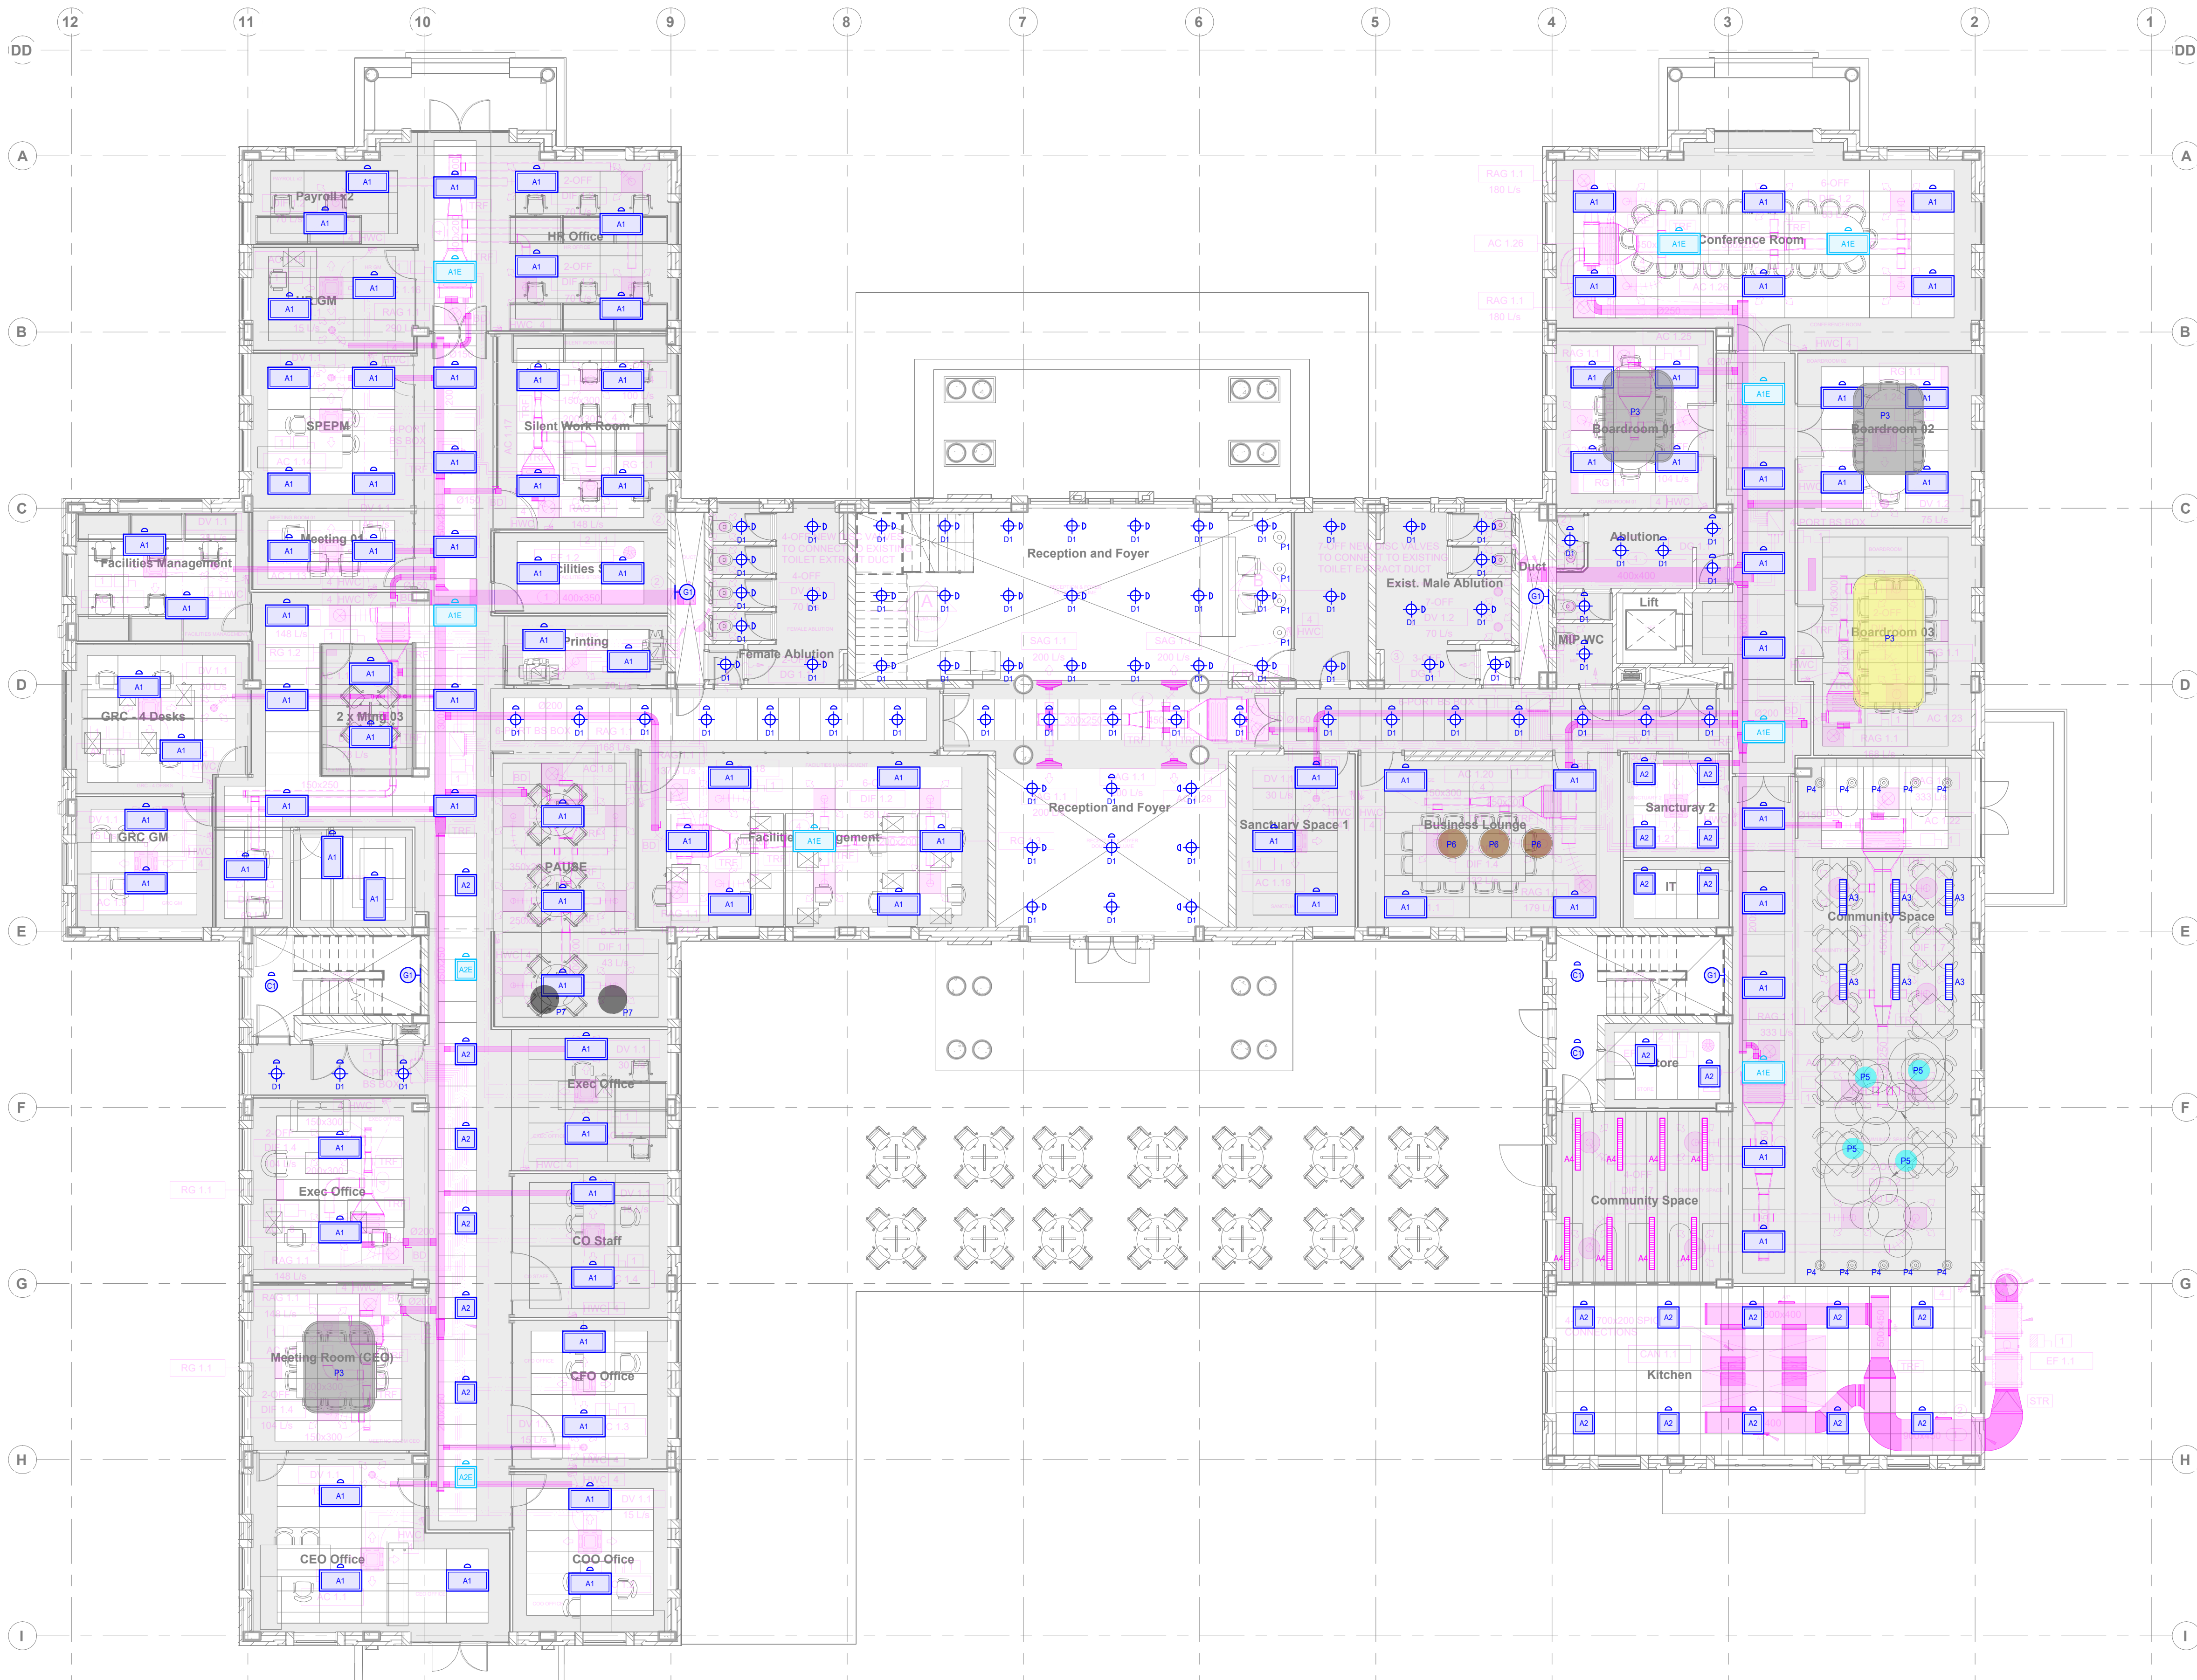

**GROUND FLOOR
LIGHTING LAYOUT**
SCALE 1:100

GENERAL NOTES

- A) THE ELECTRICAL INSTALLATION AND COMPONENTS SHALL BE SELECTED, PROCURED AND INSTALLED STRICTLY IN ACCORDANCE WITH THE OCCUPATIONAL HEALTH AND SAFETY ACT (ACT 85 OF 1993), SANS10142 PART 1 & 2 (THE WIRING OF PREMISES) AND SANS10400 (BUILDING REGULATIONS).
- B) THIS DRAWING IS TO BE READ IN CONJUNCTION WITH ALL RELEVANT DRAWINGS AND CONTRACT SPECIFICATIONS, WHICH CAN BE MADE AVAILABLE ON REQUEST.
- C) ANY DISCREPANCIES SHOULD BE BROUGHT TO CONSULTANTS ATTENTION PRIOR TO IMPLEMENTATION OF ANY WORK.
- D) ANY DRAWING IS ONLY CONTRACTUALLY VALID IF:
- STAMPED FOR CONSTRUCTION/PRELIMINARY INFORMATION.
- SIGNED IN BOTH THE CHECKED AND APPROVED BOXES.
- E) LOW VOLTAGE & MEDIUM VOLTAGE SWITCHGEAR, CABLES, ACCESSORIES, ASSEMBLIES, INSTALLATION METHODS AND MATERIALS ARE TO BE FULLY SANS COMPLIANT AND ARE TO BARE THE SABS STAMP OF APPROVAL WHERE REQUIRED.
- F) ALL ELECTRICAL WALL OUTLETS ARE MEASURED FROM THE TOP OF THE FINISHED FLOOR LEVEL TO THE BOTTOM EDGE OF THE WALL BOX.

ELECTRICAL LEGEND

	BIOLUX 1200mm x 600mm, 40W, 4000K, 5600m UGR19 LOW GLARE L80-B10 FLICKER FREE LED PANEL COMPLETE WITH VOSSLOH DRIVER (OR EQUAL APPROVED)
	BIOLUX 600mm x 600mm, 40W, 4000K, 5600m UGR19 LOW GLARE L80-B10 FLICKER FREE LED PANEL COMPLETE WITH VOSSLOH DRIVER (OR EQUAL APPROVED)
	SAME AS 'A1' FITTING ABOVE BUT COMPLETE WITH BATTERY PACK
	SAME AS 'A2' FITTING ABOVE BUT COMPLETE WITH BATTERY PACK
	2 CHANNEL 1200mm LIGHT FITTING
	CEILING LIGHT FITTING
	CEILING DOWNPANTO 2210 ROUND GU10 78mm DOWNLIGHT COLOUR: WHITE SUPPLIER: LIGHTING CO ZA OR SIMILAR APPROVED BY ELECTRICAL ENGINEER
	SIMILAR TO 'D1' + (VAPOR PROOF)
	WALL MOUNTED LIGHT FITTING
	WALL MOUNTED LIGHT FITTING (VAPOR PROOF)
	STRIP LIGHT FITTING
	MOTION SENSOR
	LIGHT SWITCH
	LIGHT SWITCH WITH DIMMER
	2-WAY LIGHT SWITCH WITH DIMMER
	3-WAY LIGHT SWITCH WITH DIMMER
	BOLLARD LIGHT
	DAYLIGHT SWITCH
	POWER OUTLET IN CEILING FOR LIGHTING
	DORA PENDANT LIGHT COLOUR: CORAL ROSE AND WOOD SUPPLIER: WIRE WORLD OR SIMILAR APPROVED BY ELECTRICAL ENGINEER
	FIRE AND ICE RECYCLED GLASS CHANDELIER COLOUR: GREEN GRASS WITH SILVER ZWIRE SIZE: 700 x 2500mm ARTIST: STEPHEN PIKUS
	SUSPENDED LIGHT ON MATT SILVER RODS COLOUR: PLASCON TANGY GLOW YS-B1-1 OR SIMILAR APPROVED BY ELECTRICAL ENGINEER
	COLOUR REF: PLASCON TAYLOR EYES P1-A1-2 SUPPLIER: WIRE WORLD OR SIMILAR APPROVED BY ELECTRICAL ENGINEER
	LUKE LINEAR LED PENDANT LIGHT COLOUR: WHITE SUPPLIER: ELEVEN PAST OR SIMILAR APPROVED BY ELECTRICAL ENGINEER
	ROPE DISC PENDANT LIGHTS COLOUR REF: PLASCON TAYLOR EYES P1-A1-2 SUPPLIER: WIRE WORLD OR SIMILAR APPROVED BY ELECTRICAL ENGINEER
	SLIMLINE LINEAR LIGHTS TO BE APPROVED BY ELECTRICAL ENGINEER
	WOVEN PENDANT LIGHT NATURAL FIBRE TO BE APPROVED BY ELECTRICAL ENGINEER
	WOVEN PENDANT LIGHT COLOUR CORD TO BE APPROVED BY ELECTRICAL ENGINEER
	WOVEN PENDANT LIGHT YELLOW COLOUR CORD TO BE APPROVED BY ELECTRICAL ENGINEER
	PURPOSE MADE LIGHTS AS PER DETAIL DRAWING

B	12-09-2025	DA	ISSUED FOR INFORMATION	S.R.	S.R.
A	10-09-2025	DA	ISSUED FOR INFORMATION	S.R.	S.R.
REV	DATE	BY	DESCRIPTION	CHK	APP
DRAWING STATUS: FOR INFORMATION					



CLIENT: SA TOURISM

ARCHITECT: **THE GREY & WHIPPET** ARCHITECTURE

PROJECT: SA TOURISM BUILDING OFFICE REVAMP

TITLE: ELECTRICAL SERVICES GROUND FLOOR LIGHTING LAYOUT

SCALE @ A1: 1:100	CHECKED: SR	APPROVED: SR
CAD FILE: 24076-E100	DESIGN-DRAWN: SR / DA	DATE: 19-08-2025
PROJECT No: 24076	DRAWING No: E100	REV: B
© Anderson Consulting Engineers (Pty) Ltd		